



Notes: Electrical to come up through basement w/GFI requirement (to be installed by a licensed, insured electrician). Post installed near pool filter system w/outlet for plug-in. Pool filter requires 110/20 amp service.

Pool to be installed by a licensed, insured general contractor (KJD Enterprises 860/569-6927).

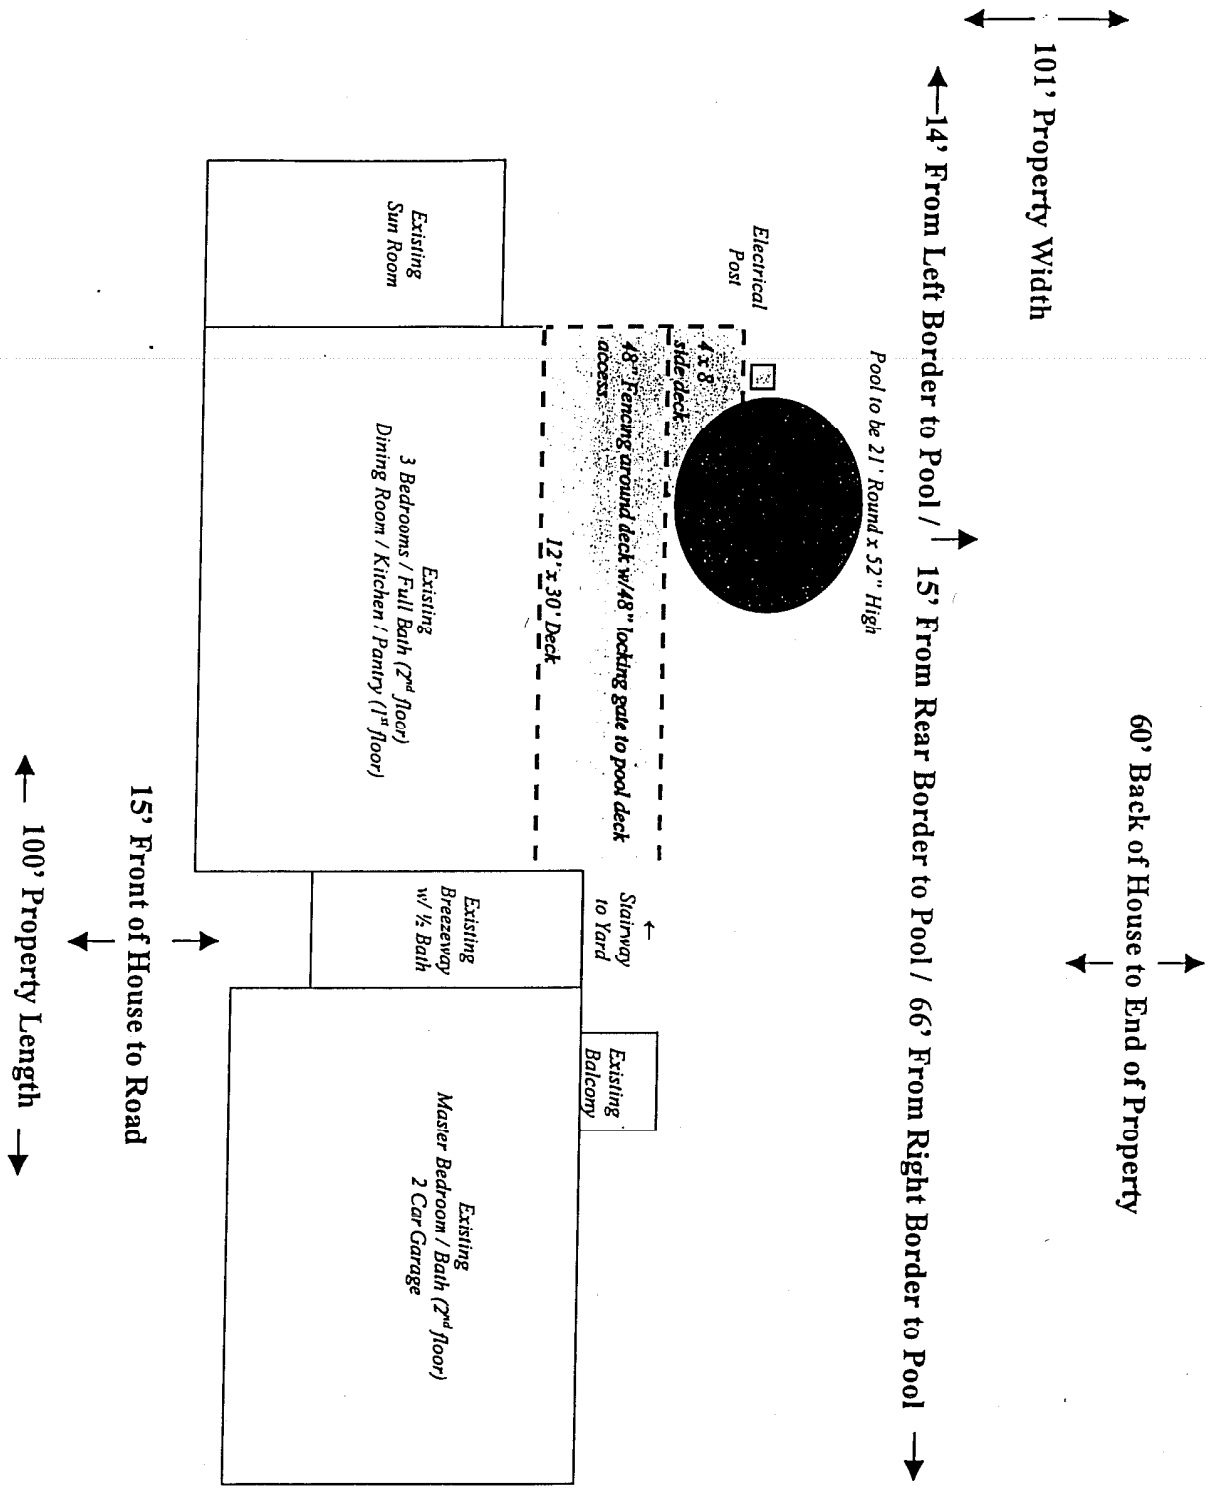


Sample Site Plan #1

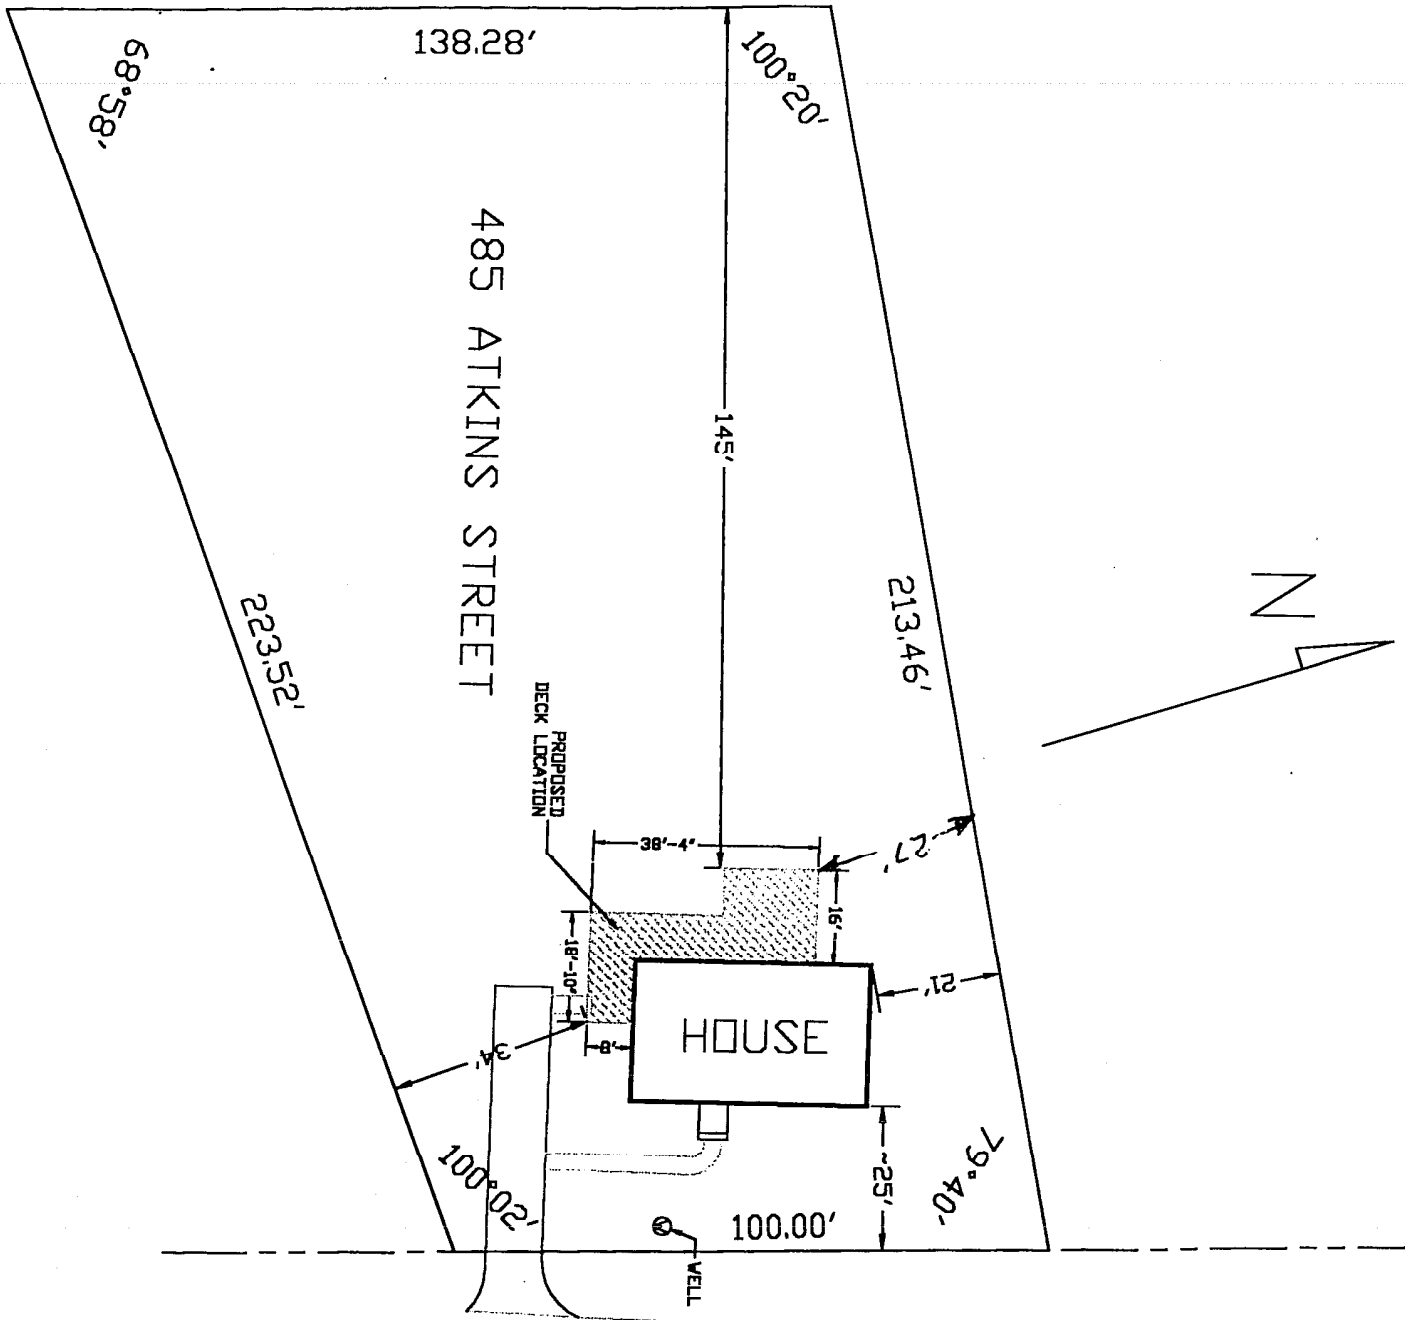

ATKINS STREET
 Sample Site Plan #2

Sample Site Plan #3

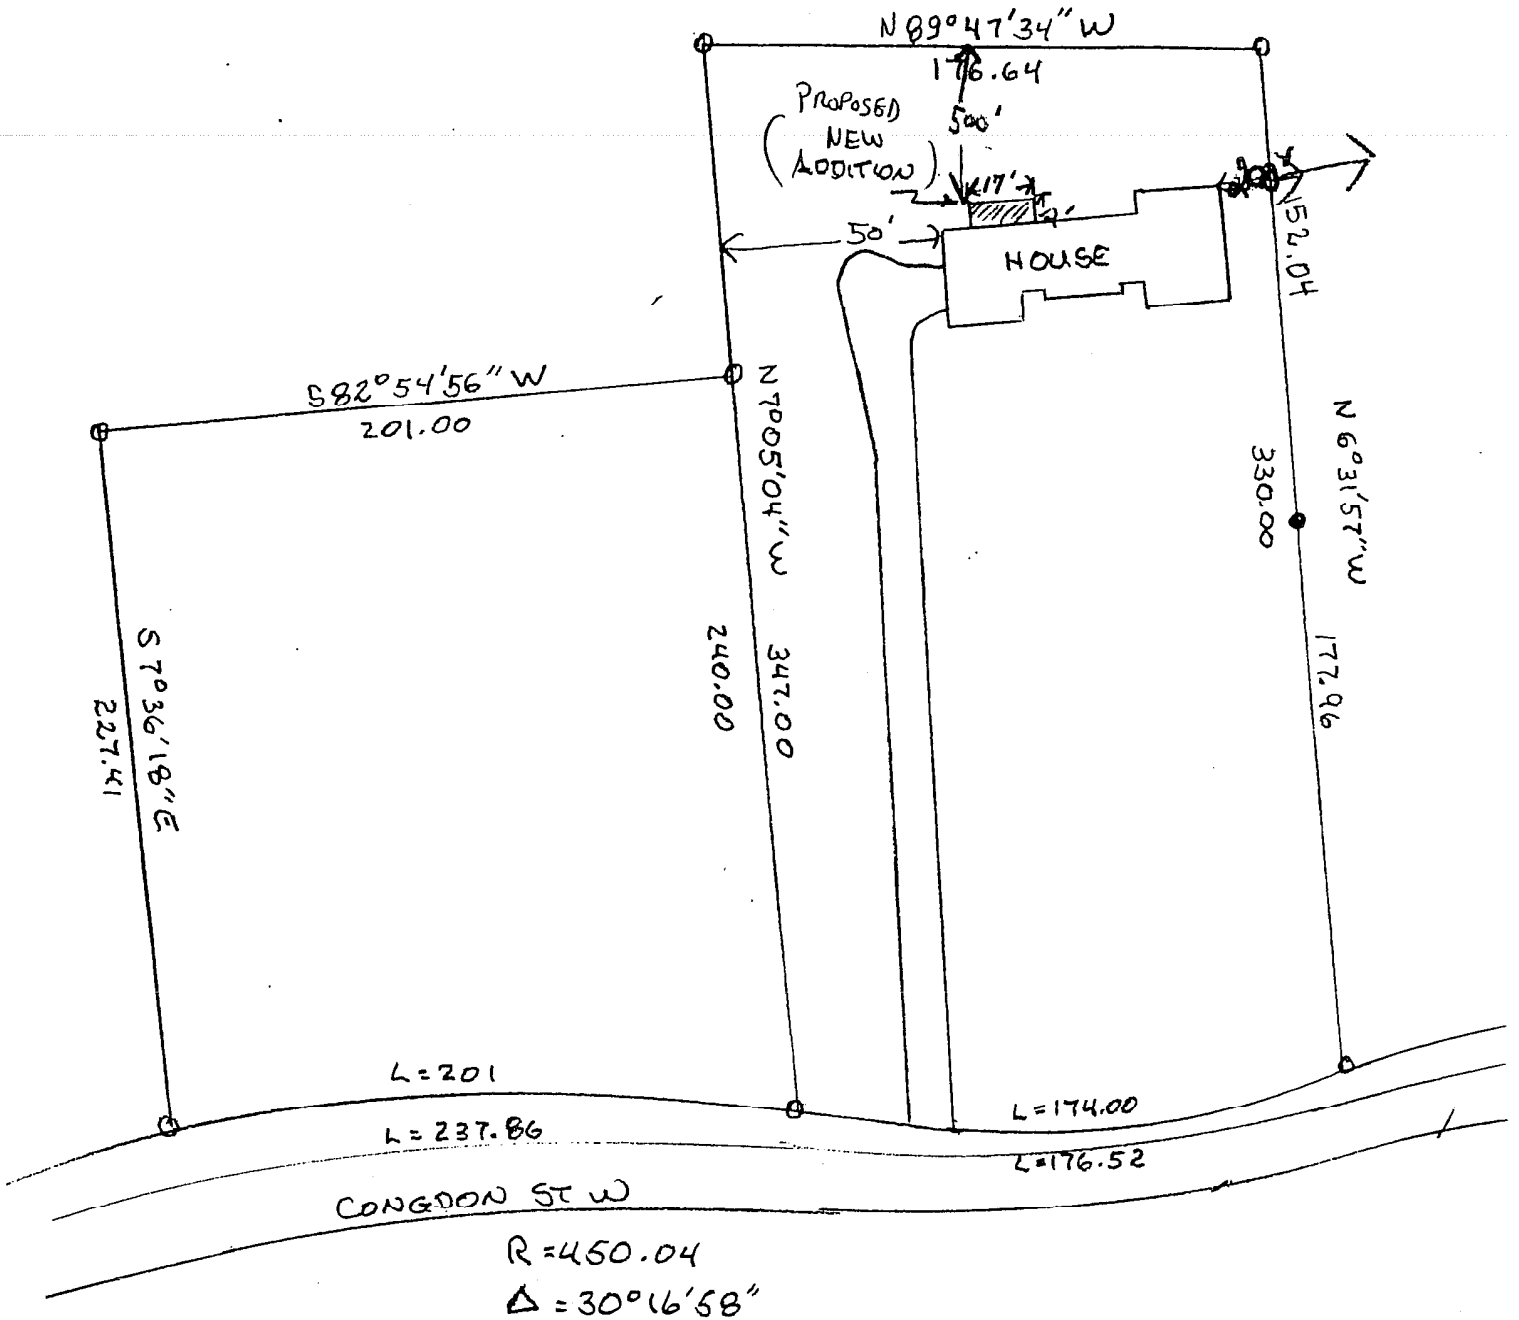


MAP REFERENCES
TOWN CLERK

- 2774
- 2995
- 3001
- 89-0
- 947.3
- 0000

SCALE 1" = 60'

- FOIP
- IR TO BE SET

Sample Site Plan # 4

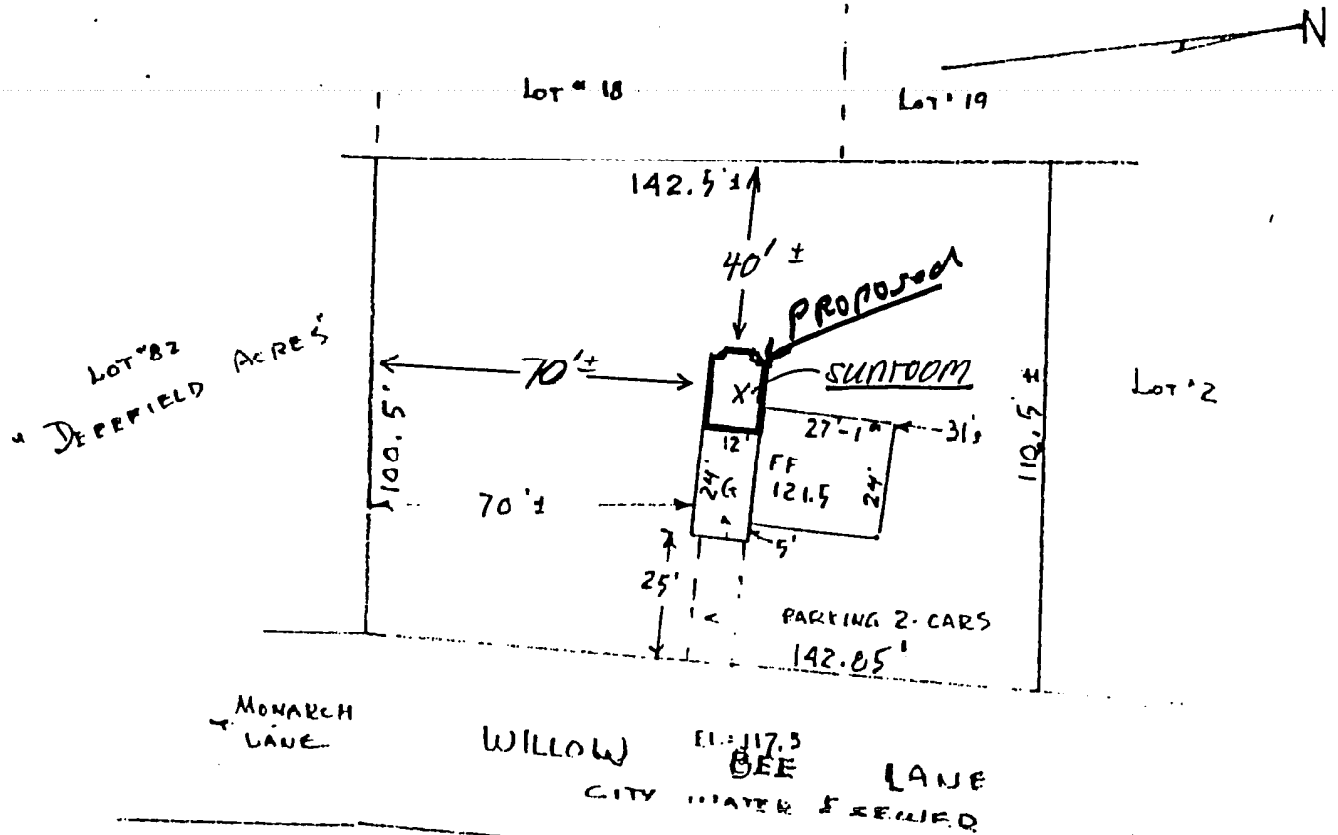

Permit 2829

Plot Plan

LOT #1 - WILLOW BEE LANE
OFF MONARCH LANE MID. CONN.
MONARCH BUILDERS & DEVELOPERS

SCALE: 1" = 40' JULY 1972

M.D. HELT GOTT P.E. L.S.

MIDDLETOWN, CONN.

CERTIFIED
SUBSTANTIALLY CORRECT:

Mattfgoth

